



PRELIMINARY DRAWING

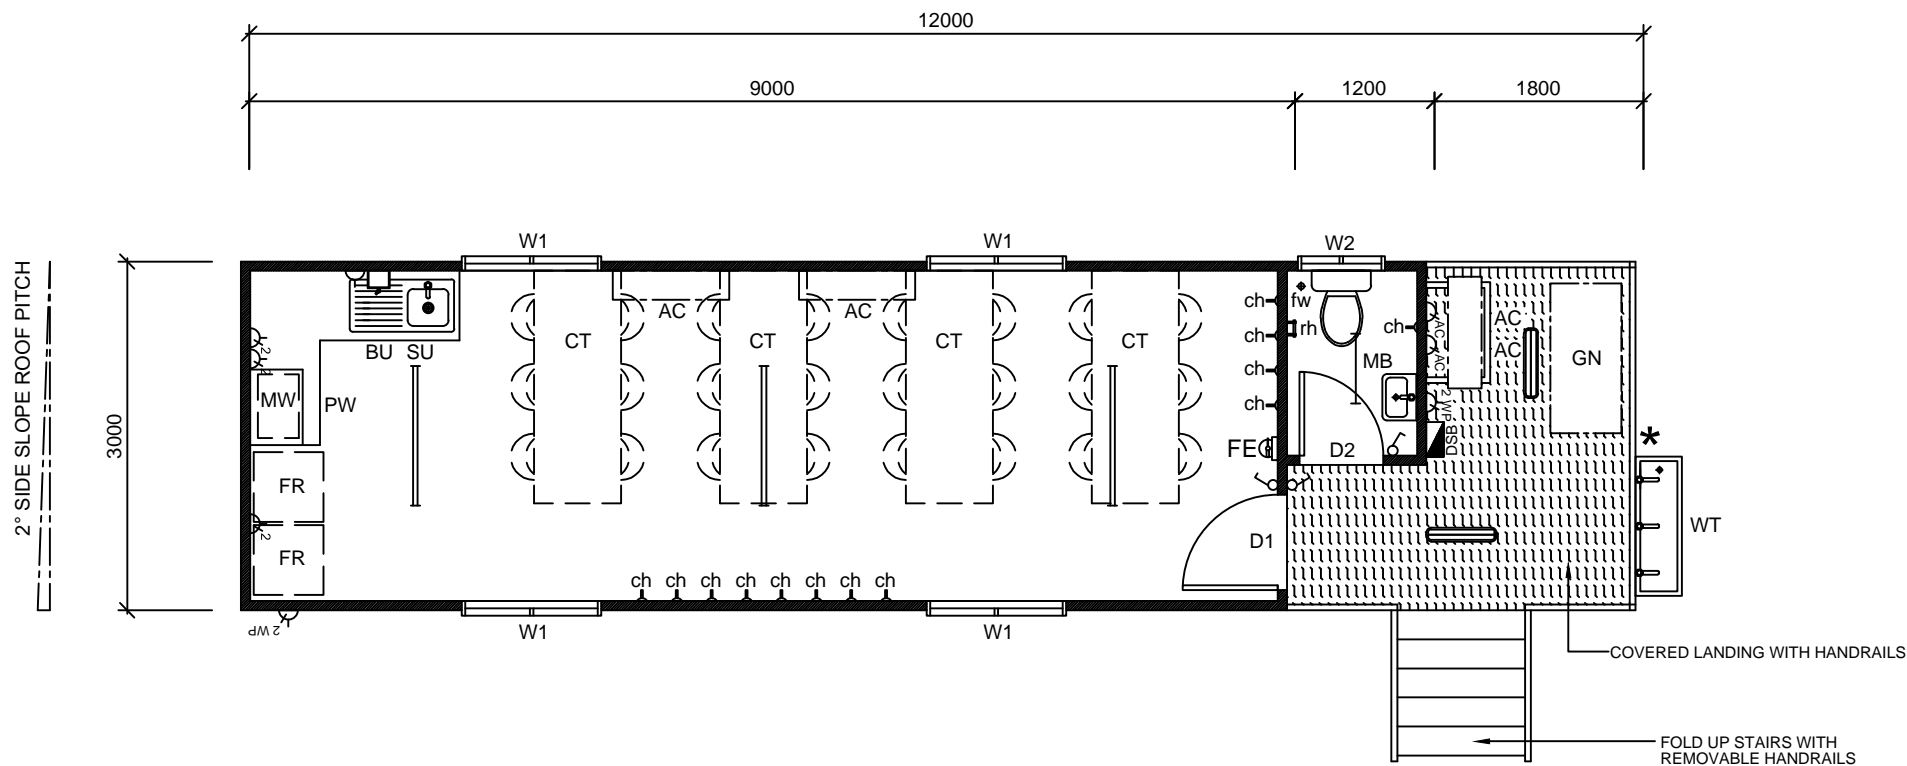

12.0x3.0m Mobile Crib Room - Floor Plan

Scale 1:75

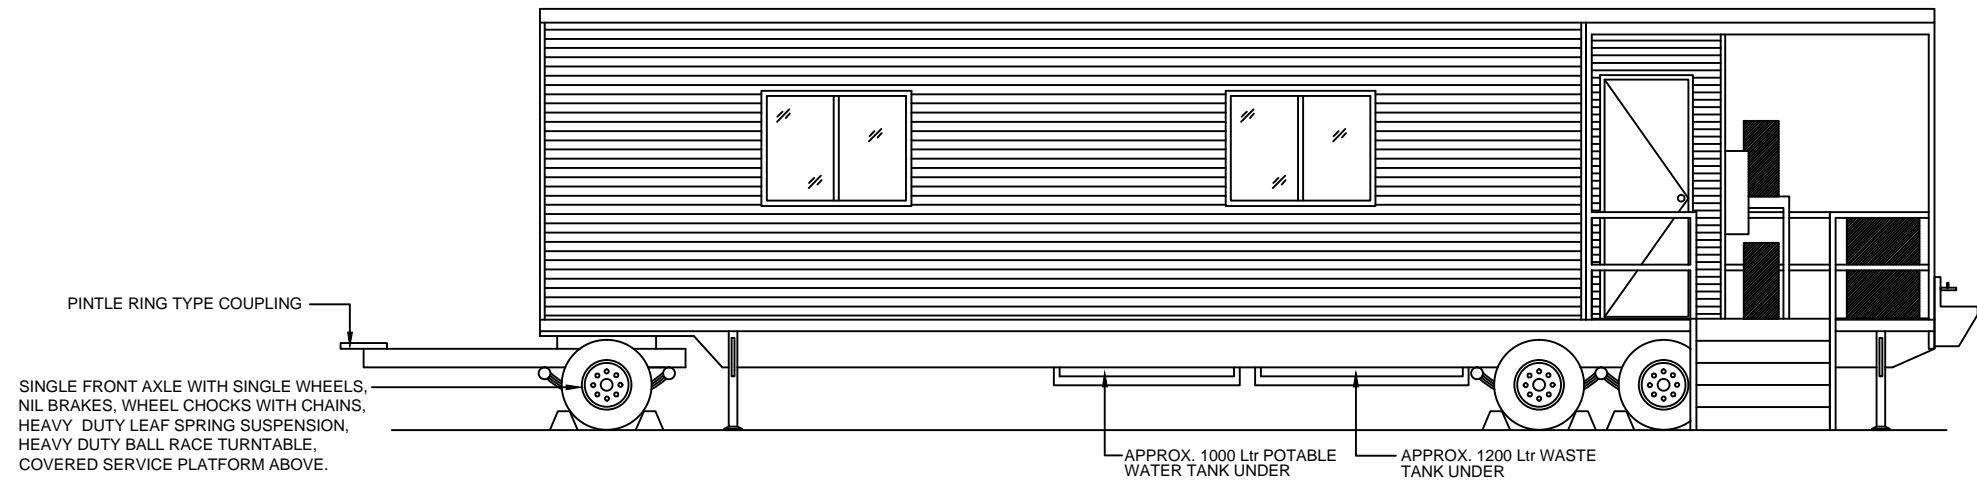

12.0x3.0m Mobile Crib Room - Front Elevation

Scale 1:75

Item List

Item	Qty	Description
D1	x(1)	2040x820mm External Metal Clad Door With Glass Viewing Panel - Grey Glass & Door Closer.
D2	x(1)	2040x720mm External Metal Clad Door With Door Closer.
W1	x(4)	900x1200mm Sliding Glass Window - Grey Glass With Flyscreen & Holland Blind
W2	x(1)	300x750mm Obscure Glass Vented Window With Flyscreen.
AC	x(2)	2.5kw Mitsubishi Heavy Industries Reverse Cycle Split System Reverse Cycle Air Conditioner. External Units Mounted On Custom Frame For Mounting One Unit Over The Other.
GN	x(1)	9kVA Mine Spec Diesel Generator.
SU	x(1)	2700mm Bench Top & Splashback, Lockable Cupboards & Single Drawer Under, Single Bowl Single Drainer (Cold Only)
BU	x(1)	3.0 Ltr Boiling Water Unit - Wall Mounted.
FR	x(2)	240 Ltr All Fridge.
MW	x(1)	30 Ltr Microwave.
PW	x(1)	Pie Warmer (50 Pie Capacity).
CT	x(4)	2000x700mm Stainless Steel Crib Table With 6x Chairs.
WT	x(1)	1200mm Stainless Steel Wash Trough With 3 Taps (Cold).

Item List

Item	Qty	Description
WC	x(1)	Toilet Pan With Dual Flush Cistren.
MB	x(1)	Compact Stainless Steel Hand Basin - Cold Only.
FE	x(1)	4.5kg ABE Fire Extinguisher & Sign.
ch	x(25)	Coat Hook (*2x Rows Of 12 Hooks, + 1x Single Hook).
rh	x(1)	Roll Holder.
fw	x(1)	Floor Waste.

Notes

- Steel Frame Construction.
- Pre-finished Plywood Internal Walls & Ceiling Lining.
- Coved Commercial 2mm Vinyl Floor Covering In Crib Room Area.
- Coved R10 Slip Resistant Vinyl In Wet Areas
- Approx. 1000 Ltr Potable Water Tank With Water Pump, Mounted Within Trailer Frame.
- Approx. 1200 Ltr Waste Tank, Mounted Within Trailer Frame With Chemlock Fitting For Pump Out.
- Unregistered Trailer With Maximum Trailer Towing Speed of 20km Per Hour. Trailer Designed To Be Used On Mine Sites / Construction Sites Only.

Electrical Legend

Icon	Qty	Description
	x(1)	Metal External Distribution Switchboard (Lockable) With Double Pole Main Switch, Double Pole Circuit Breakers Fitted With Cirlock Metal Lockouts.
	x(3)	Light Switch.
	x(1)	10amp Single GPO.
	x(3)	10amp Double GPO.
	x(2)	10amp Double Weatherproof GPO.
	x(2)	External Isolator Switch - Split AC.
	x(1)	18 Watt Single Fluorescent Light.
	x(3)	36 Watt Double Fluorescent Light.
	x(2)	18 Watt Vandalite.
	x(1)	Flashing Amber Beacon.

Colour Schedule

External		
Cladding	-	Colorbond
Roof	-	Zincalume
Flashings	-	Colorbond
Capping	-	Colorbond
Door	-	Colour
Windows	-	Colour

Internal		
Vinyl	-	Grey
Vinyl (R10)	-	Grey
Walls	-	Grey
Ceiling	-	White
Cabinetry	-	White

CLIENT APPROVAL

Signature: _____ Date: _____

Rev.	Description	Date	By
A	Issued for Client Review	27/03/17	BW



THIS DRAWING AND DESIGN IS THE SOLE PROPERTY OF JABEGIL PTY LTD T/A MULTITRADE BUILDING HIRE A.B.N. 36 010 138 600 IT MAY NOT BE REPRODUCED, COPIED WHOLE OR IN PART WITHOUT WRITTEN AUTHORITY.

CLIENT		DATE
PEAK DOWNS MINE		27/03/17
TITLE		SCALE
12.0x3.0m MOBILE CRIB ROOM		1:50
DESIGN WIND LOAD	DRAWN	CHECKED
	BW	
DRAWING NUMBER	REVISION	SHEET SIZE
SQF-3077-01	A	A3