


7.2x2.4m Mobile Crib Room - Floor Plan

Scale 1:75

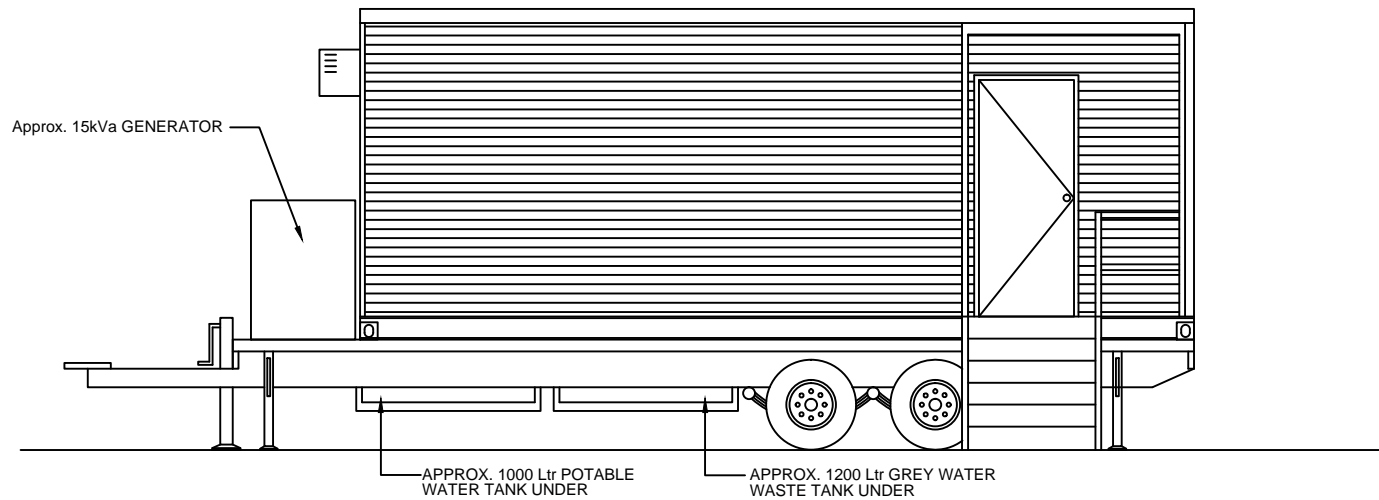

7.2x2.4m Mobile Crib Room - Front Elevaion

Scale 1:75

Item List

Item	Qty	Description
D1	x(1)	2040x880mm External Metal Clad Door With Glass Viewing Panel - Grey Glass & Door Closer.
D2	x(2)	2040x820mm External Metal Clad Door With Door Closer.
W1	x(2)	900x1200mm Sliding Glass Window - Grey Glass With Flyscreen & Holland Blind
W2	x(1)	300x750mm Obscure Glass Vented Window
AC	x(1)	Wall Mounted Reverse Cycle Room Air Conditioner
SU	x(1)	1800mm Bench Top & Splashback, Cupboards & Single Drawer Under, Single Bowl Single Drainer (Cold Only)
BU	x(1)	Boiling Water Unit - Wall Mounted
CT	x(1)	Chemical Toilet With Built In Hand Basin
HB	x(1)	Stainless Steel Hand Basin - Cold Only (External)
ch	x(8)	Coat Hook
rh	x(1)	Roll Holder
fw	x(1)	Floor Waste

Notes

- Pre-finished Plywood Internal Walls & Ceiling Lining.
- Commercial Vinyl Floor Covering
- Coved R10 Slip Resistant Vinyl In Wet Areas
- Approx. 1000 Ltr Potable Water Tank With Water Pump, Mounted Within Trailer Frame
- Approx. 1200 Ltr Grey Water Waste Tank, Mounted Within Trailer Frame With Chemlock Fitting For Pump Out.

* Tables & Chairs - By Others

Electrical Legend

Icon	Qty	Description
	x(1)	Metal External Distribution Switchboard (Lockable) With Double Pole Main Switch Double Pole Circuit Breakers.
	x(3)	Light Switch
	x(2)	10amp Single GPO
	x(4)	10amp Double GPO
	x(1)	10amp Double Weatherproof GPO
	x(1)	18 Watt Single Fluorescent Light
	x(2)	36 Watt Double Fluorescent Light
	x(1)	18 Watt Vandalite

Colour Schedule

External

Cladding	-	Colorbond
Roof	-	Zincalume
Flashings	-	Colorbond
Capping	-	Colorbond
Door	-	Colour
Windows	-	Colour

Internal

Vinyl	-	Grey
Vinyl (R10)	-	Grey
Walls	-	Grey
Ceiling	-	White
Cabinetry	-	White



MULTITRADE
6 SOUTH TREES DRIVE
PO BOX 642
GLADSTONE
4680, QLD, AUSTRALIA

Phone: 07 4979 2333
Fax: 07 4979 1698
Email: multitrade@hotmail.net.au

www.multitrade.com.au

THIS DRAWING AND DESIGN IS THE SOLE PROPERTY OF JABEGIL PTY LTD T/A MULTITRADE BUILDING HIRE A.B.N. 36 010 138 600 IT MAY NOT BE REPRODUCED, COPIED WHOLE OR IN PART WITHOUT WRITTEN AUTHORITY.

CLIENT		DATE
PRIME RENTALS		31/07/13
TITLE		SCALE
7.2x2.4m MOBILE CRIB ROOM		1:50
DESIGN WIND LOAD	DRAWN	CHECKED
N/A	BW	
DRAWING NUMBER	REVISION	SHEET SIZE
SQF-1555-02	A	A3